
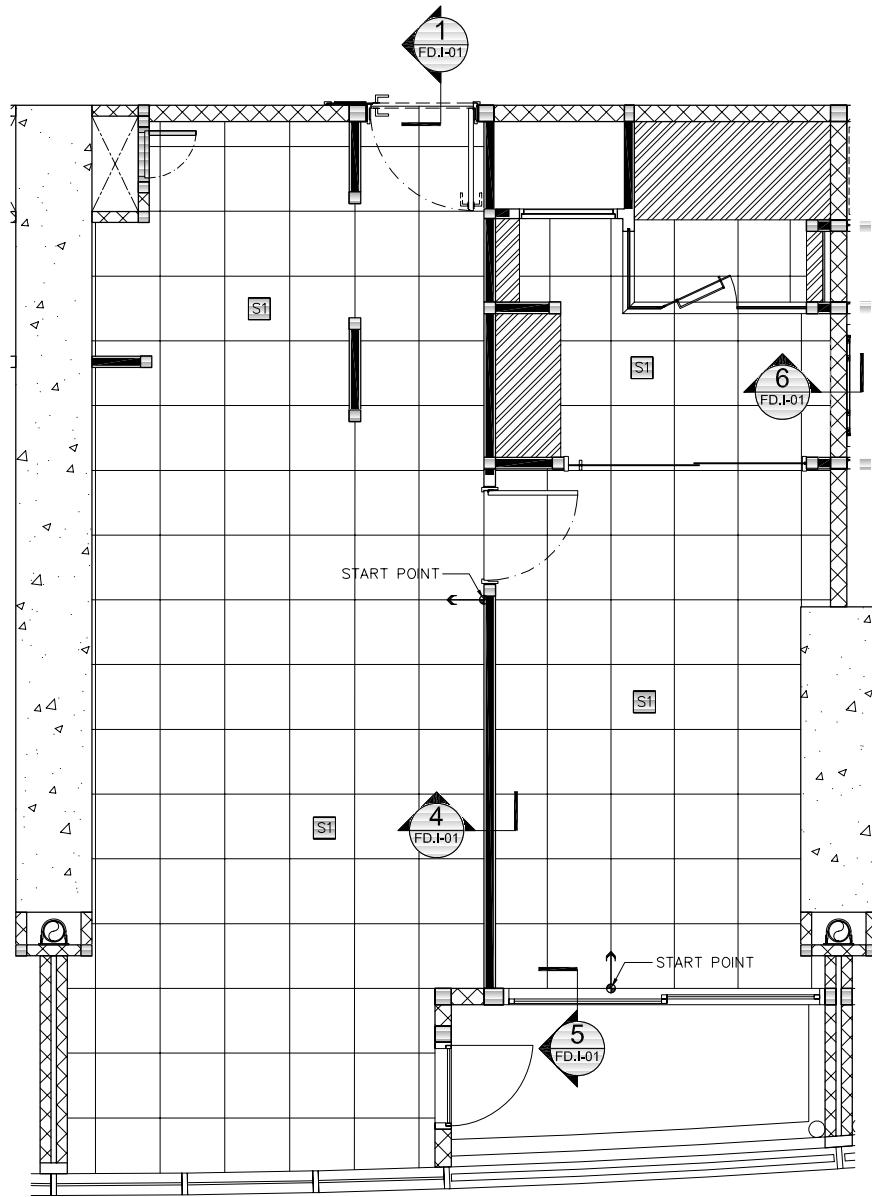


**A FURNITURE & ELETRICAL PLAN**  
SCALE : 1:50

ELECTRICAL LEGEND	
	TELEPHONE OUTLET TO BE MOUNTED IN WALL 300 mm. ABOVE FINISHED FLOOR LEVEL UNLESS OTHERWISE NOTED. ปลั๊กโทรศัพท์ผนังในผนังสูงจากพื้น 300 มม. นอกจากบางส่วนที่มีหมายเหตุ
	DOUBLE POWER OUTLET RECTANGULAR PLATE TO BE MOUNTED IN WALL 300 mm. ABOVE FINISHED FLOOR LEVEL UNLESS OTHERWISE NOTED. ปลั๊กไฟสองตัวผนังในผนังสูงจากพื้น 300 มม. นอกจากบางส่วนที่มีหมายเหตุ
	SINGLE POWER OUTLET TO BE MOUNTED IN WALL 300 mm. ABOVE FINISHED FLOOR LEVEL UNLESS OTHERWISE NOTED. ปลั๊กไฟสองตัวผนังในผนังสูงจากพื้น 300 มม. นอกจากบางส่วนที่มีหมายเหตุ
	SINGLE POWER OUTLET WATER RESISTANT TO BE MOUNTED IN WALL 300 mm. ABOVE FINISHED FLOOR LEVEL UNLESS OTHERWISE NOTED. ปลั๊กไฟสองตัวผนังในผนังสูงจากพื้น 300 มม. นอกจากบางส่วนที่มีหมายเหตุ


ELECTRICAL LEGEND	
	T.V. OUTLET TO BE MOUNTED IN WALL 300 mm. ABOVE FINISHED FLOOR LEVEL UNLESS OTHERWISE NOTED. ปลั๊กทีวีผนังในผนังสูงจากพื้น 300 มม. นอกจากบางส่วนที่มีหมายเหตุ
	LAN OUTLET TO BE MOUNTED IN WALL 300 mm. ABOVE FINISHED FLOOR LEVEL UNLESS OTHERWISE NOTED. ปลั๊กสัญญาณอินเทอร์เน็ตผนังในผนังสูงจากพื้น 300 มม. นอกจากบางส่วนที่มีหมายเหตุ
	OUTLET TO BE MOUNTED IN JOINERY ปลั๊กผนังในเฟอร์นิเจอร์
	OUTLET TO BE MOUNTED IN FLOOR ปลั๊กผนังในพื้น
	THERMOSTAT
	MAIN CONTROL BOARD
	SWITCH BELL TO BE CONFIRM
	BELL BOX TO BE CONFIRM

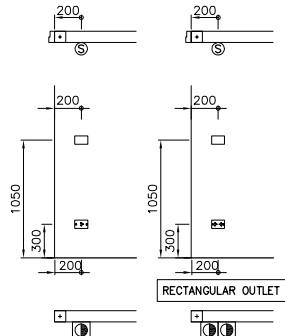

**B FLOOR FINISH PLAN**  
SCALE : 1:50

FLOOR FINISH LEGEND	
	STONE TILE 594 X 594 MM.
	CERAMIC TILE 300 X 300 MM.
	100 MM. WIDE TIMBER SOLID OAK
	CEMENT RENDER FINISH (TO BE SAME LEVEL AS FLOOR TILE)

Interior:  
**Steven J. Leach Jr. + Associates**  
A Member of the Steven Leach Group

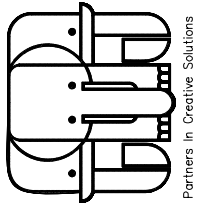

62 The Millennia Building, 10th Floor.  
Soi Langsuan, Ploenchit Road.  
Kwaeng Lumpini, Khet Pathumwan,  
Bangkok 10330, Thailand  
Tel. (662) 650-5585  
Fax (662) 650-5587  
Bkk.Gen@sla-group.com

General Notes :  
All designs are the sole property of Steven J. Leach, Jr. + Associates and may not be used without their written permission.  
All prints, specifications and their copyright are the property of Steven J. Leach, Jr. + Associates and shall be returned at the completion of the work.  
Contractor to verify all site dimensions.  
Do not scale drawings.  
Figured dimensions shall be taken in preference to scaled dimensions.  
All dimensions take checked on site before commencing any work or shop drawings. Any discrepancies occurring in these drawings must be referred to S.J.A. before the commencement of any work, or the contractor shall bear the full responsibility of the same.  
Contractor is responsible for notifying S.J.A. if any confusion arises on site or if dimensions and/or details are missing from drawing set before proceeding at site. All wood grain on moveable furniture and built-in joinery is to run in the direction as indicated by arrows on drawings.

Drawing not to be used for construction.  
Do not scale drawing.  
Use figured dimension only.

DATE	DESCRIPTION
2009 / 07 / 28	REVISION B
2008 / 10 / 07	FOR CONSTRUCTION
REVISION	

PROJECT : 2005-D-17A

**THE RIVER**  
Tower A  
BANGKOK

DRAWING TITLE :

**FURNITURE  
ELECTRICAL PLAN &  
FLOOR FINISHS PLAN**

Date:	2007 / 10 / 01	Drawing Number :
Design By:	-	<b>1-A1.I-02</b>
Drawn By:	P.J.	
Check By:	P.J.	Scale: 1:50